


HSIP5-05-010

Dist	COUNTY	ROUTE	POST MILES TOTAL PROJECT	SHEET No.	TOTAL SHEETS
05	SB	101	82.18	01	44

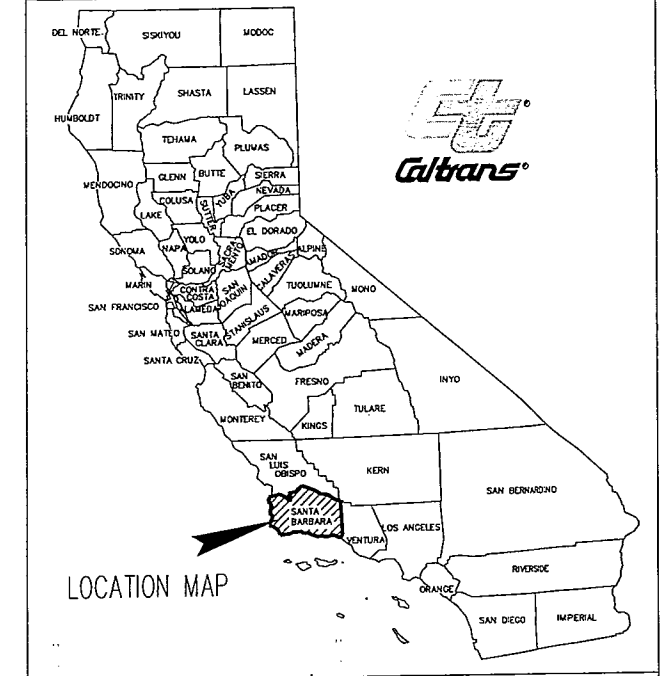

INDEX OF PLANS

SHEET NO.	DESCRIPTION
1	TITLE AND LOCATION MAP
2	KEY MAP AND LINE INDEX
3	PROJECT CONTROL
4-6	TYPICAL CROSS SECTIONS
7-10	LAYOUTS
11	PROFILE AND SUPERELEVATION DIAGRAM
12-15	CONSTRUCTION DETAILS
16-18	EROSION CONTROL PLANS
19-23	DRAINAGE PLANS, PROFILES, DETAILS, AND QUANTITIES
24-25	UTILITY PLANS
26-31	STAGE CONSTRUCTION PLANS
32-37	PAVEMENT DELINEATION AND SIGN PLANS, AND QUANTITIES
38-39	SUMMARY OF QUANTITIES
40-44	ELECTRICAL PLANS

STATE OF CALIFORNIA
 DEPARTMENT OF TRANSPORTATION
 PROJECT PLANS FOR CONSTRUCTION ON
 STATE HIGHWAY AND COUNTY ROAD

IN COUNTY OF SANTA BARBARA
 IN AND NEAR ORCUTT
 FROM 0.1 MILES WEST OF CLARK AVENUE OVERCROSSING TO 0.2
 MILES EAST OF CLARK AVENUE OVERCROSSING

TO BE SUPPLEMENTED BY STANDARD PLANS DATED 2018.

COUNTY PROJECT NO. 862331

APPROVED AS TO IMPACT ON STATE FACILITIES AND CONFORMANCE WITH APPLICABLE STATE STANDARDS AND PRACTICES AND THAT TECHNICAL OVERSIGHT WAS PERFORMED.

DATE SIGNED 8/29/19


LICENSE Exp DATE 09/30/20

REGISTRATION No. 48016

CALTRANS DESIGN OVERSIGHT APPROVAL

CLAUDIA A. ESPINO

CONSULTANT DESIGN MANAGER DEREK RAPP

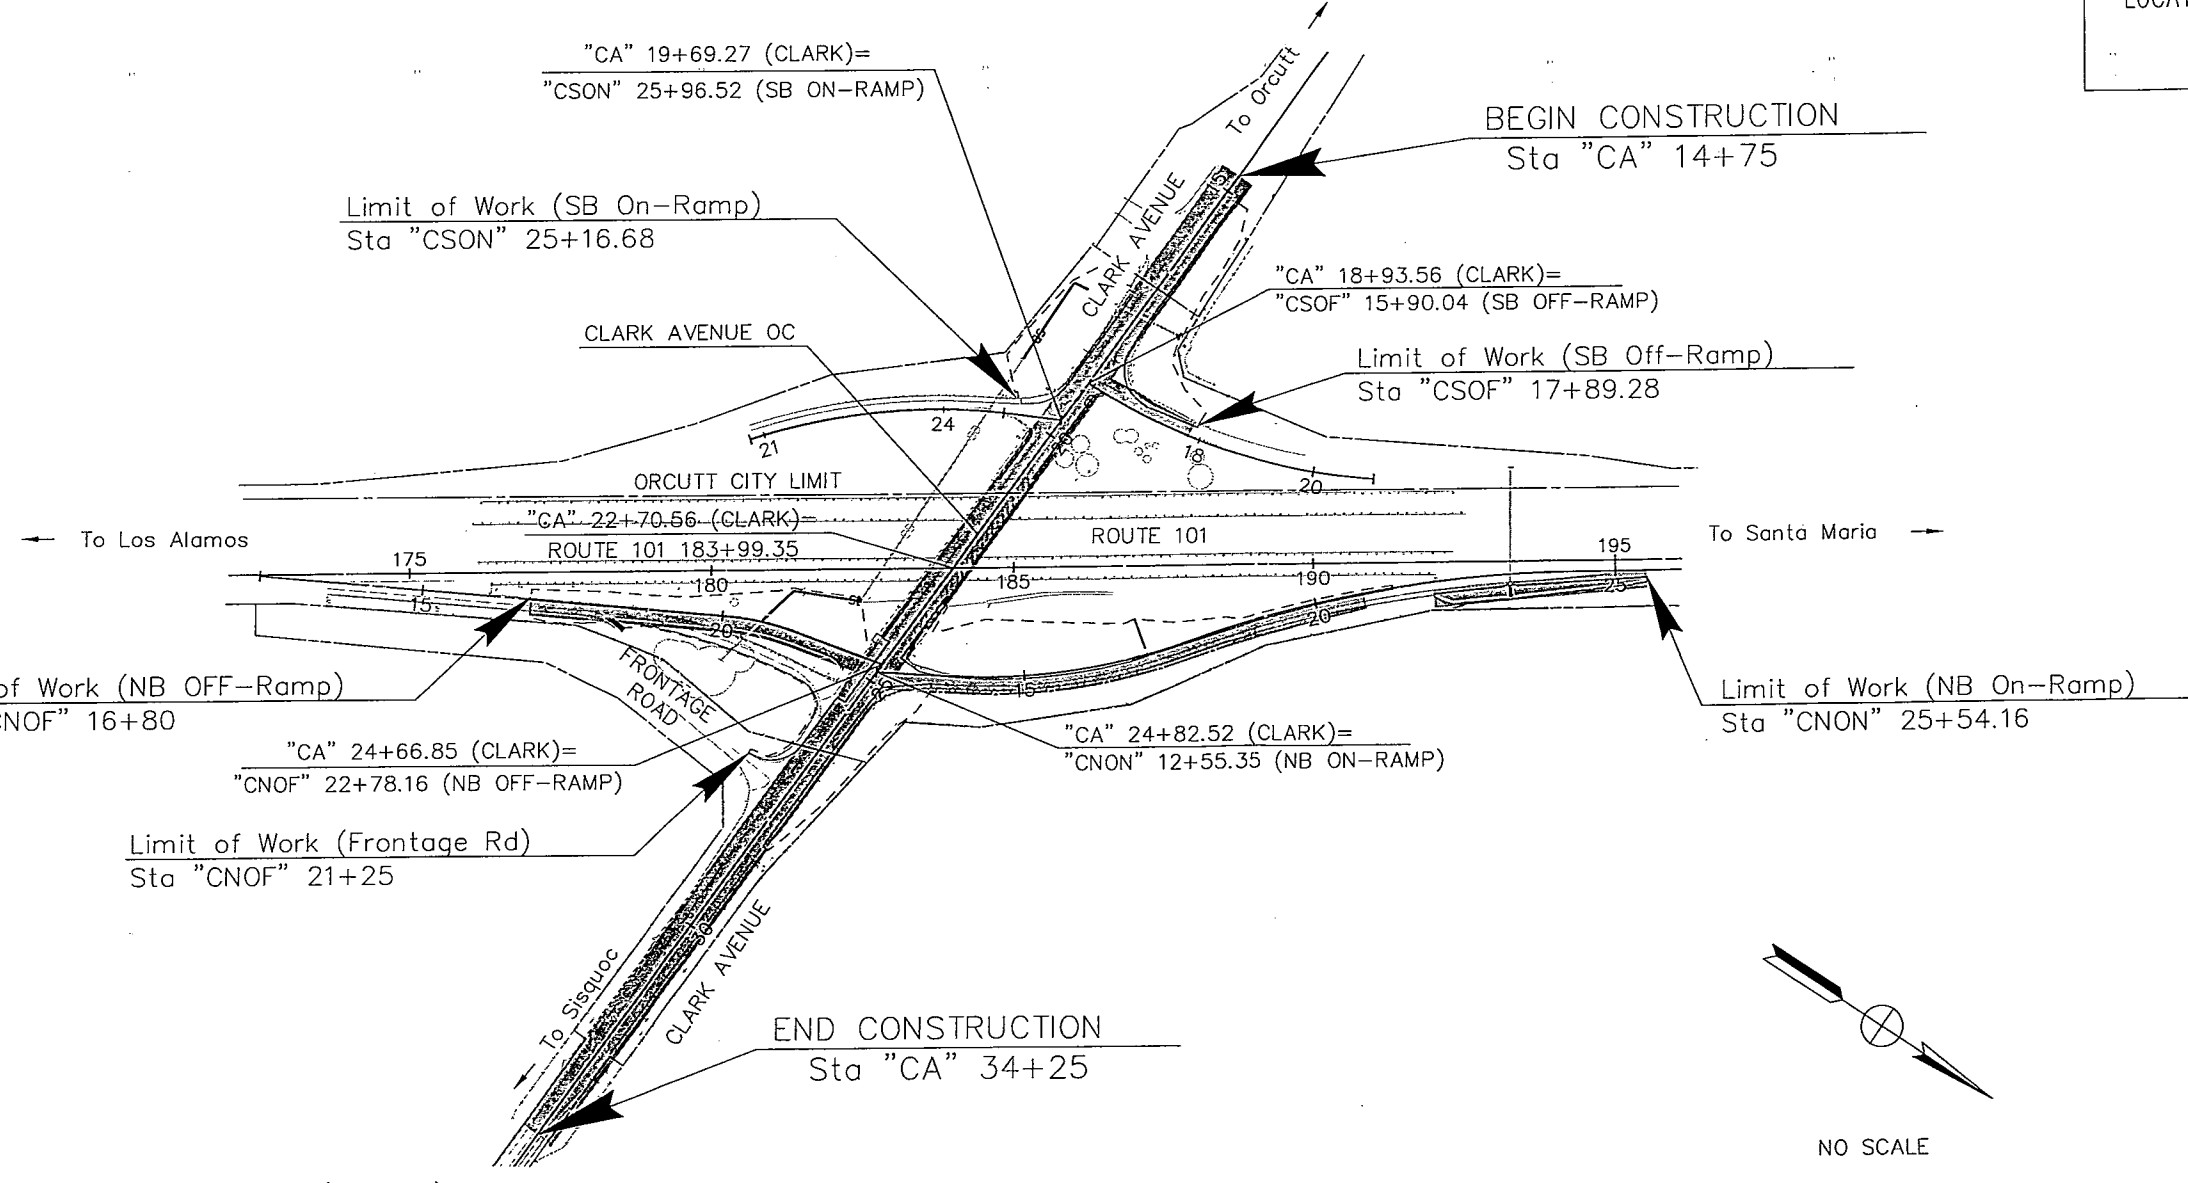

Stacy Swain 12-17-19
 APPROVED - CHAIR, BOARD OF SUPERVISORS DATE

Alisa Folsom 8/28/19
 APPROVED - DIRECTOR OF PUBLIC WORKS DATE

Walter Rabolewicz 8/26/19
 APPROVAL RECOMMENDED - ENGINEERING SECTION MANAGER DATE

Heather Gardner 08/12/19
 PROJECT ENGINEER DATE
 REGISTERED CIVIL ENGINEER

HEATHER GARDNER
 No. 86989
 Exp. 03/31/21
 CIVIL
 STATE OF CALIFORNIA

STANTEC CONSULTING
 2646 SANTA MARIA WAY, SUITE 107
 SANTA MARIA, CA 93455
 COUNTY OF SANTA BARBARA
 DEPARTMENT OF PUBLIC WORKS
 123 EAST ANAPAMU STREET
 SANTA BARBARA, CA 93101

CONTRACT No. 05-1F1004
 PROJECT ID 0513000057

THE CONTRACTOR SHALL POSSESS THE CLASS (OR CLASSES) OF LICENSE AS SPECIFIED IN THE "NOTICE TO BIDDERS."

DATE PLOTTED => \$DATE TIME PLOTTED => \$TIME