

INDEX OF PLANS

SHEET NO.	DESCRIPTION
1	TITLE AND LOCATION MAP
2	KEY MAP AND LINE INDEX
3	PROJECT CONTROL
4-6	TYPICAL CROSS SECTIONS
7-10	LAYOUTS
11	PROFILE AND SUPERELEVATION DIAGRAM
12-15	CONSTRUCTION DETAILS
16-18	EROSION CONTROL PLANS
19-23	DRAINAGE PLANS, PROFILES, DETAILS, AND QUANTITIES
24-25	UTILITY PLANS
26-31	STAGE CONSTRUCTION PLANS
32-37	PAVEMENT DELINEATION AND SIGN PLANS, AND QUANTITIES
38-39	SUMMARY OF QUANTITIES
40-44	ELECTRICAL PLANS


STATE OF CALIFORNIA  
DEPARTMENT OF TRANSPORTATION  
PROJECT PLANS FOR CONSTRUCTION ON  
STATE HIGHWAY AND COUNTY ROAD

IN COUNTY OF SANTA BARBARA  
IN AND NEAR ORCUTT  
FROM 0.1 MILES WEST OF CLARK AVENUE OVERCROSSING TO 0.2  
MILES EAST OF CLARK AVENUE OVERCROSSING


TO BE SUPPLEMENTED BY STANDARD PLANS DATED 2018  
COUNTY PROJECT NO. 862331

HSIP5-05-010

DIST	COUNTY	ROUTE	POST MILES TOTAL PROJECT	SHEET No.	TOTAL SHEETS
05	SB	101	92.18	01	44

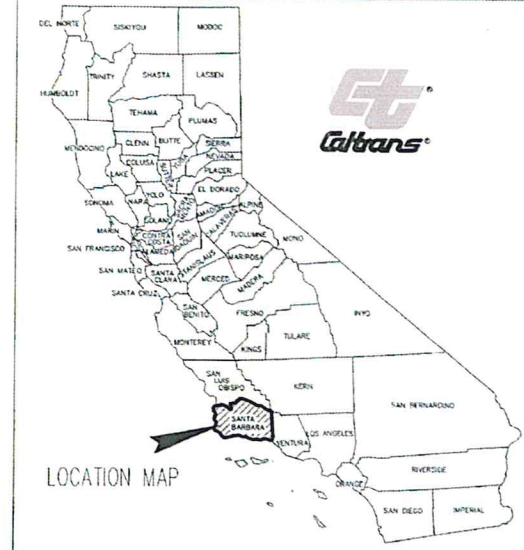

APPROVED - CHAIR, BOARD OF SUPERVISORS DATE 8/28/19  
 APPROVED - DIRECTOR OF PUBLIC WORKS DATE 8/28/19  
 APPROVAL RECOMMENDED - ENGINEERING SECTION MANAGER DATE 8/28/19

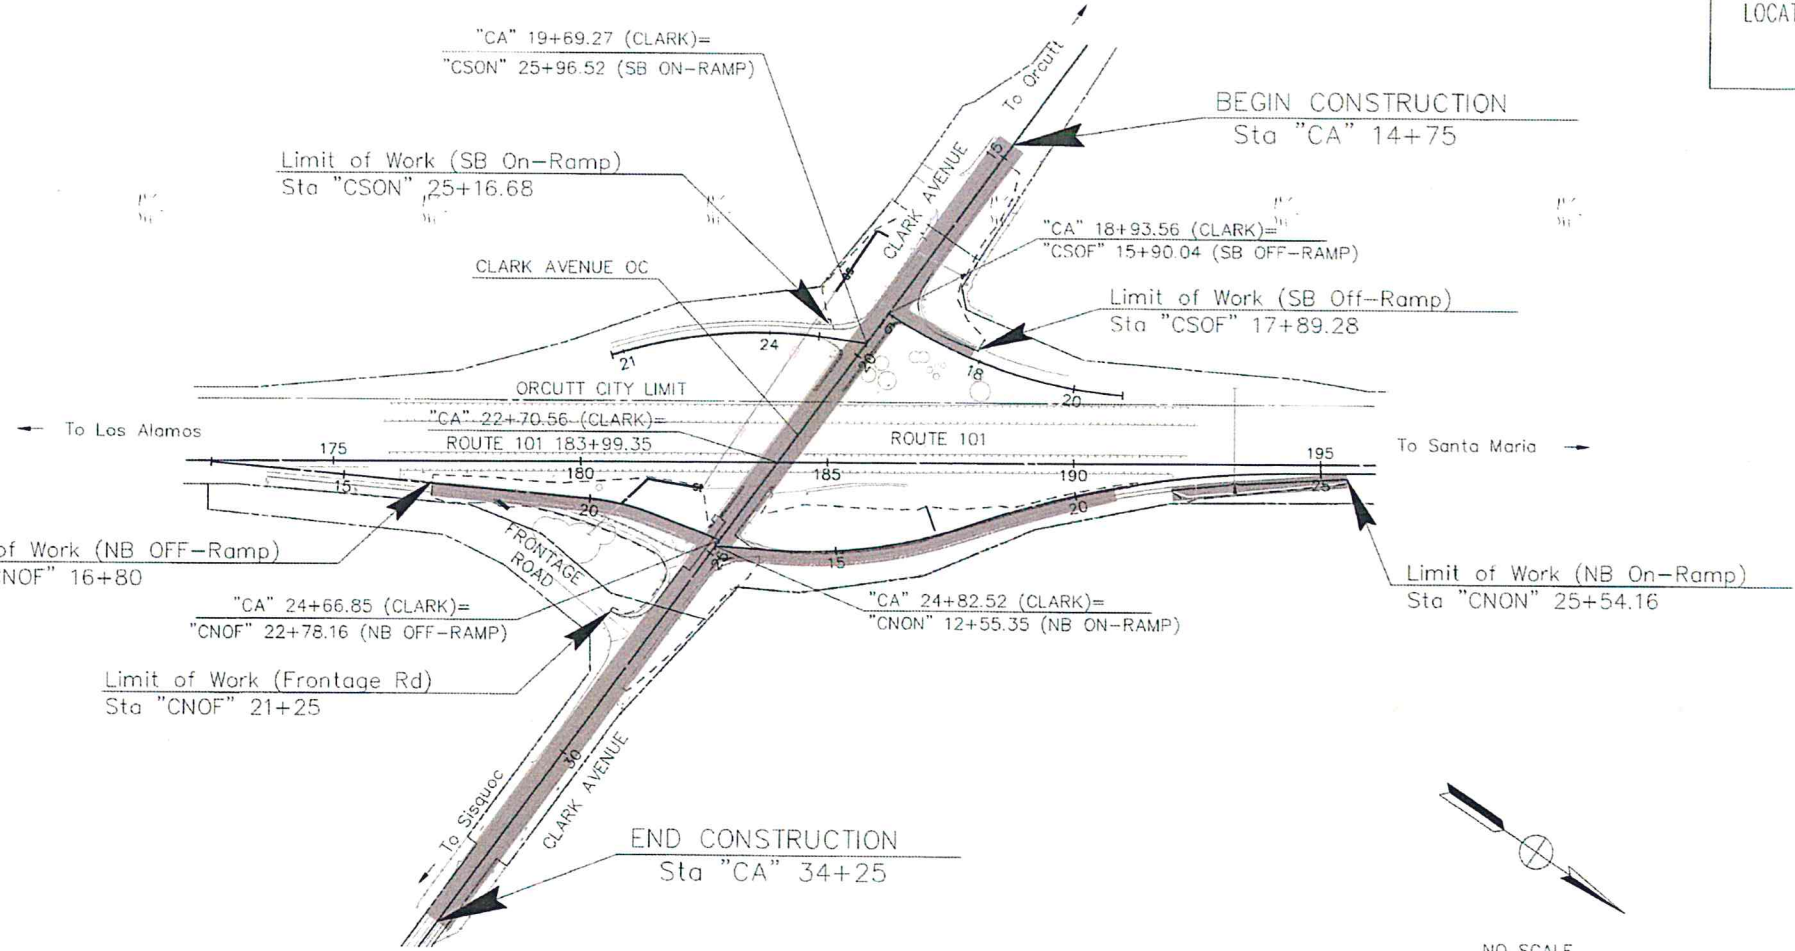

PROJECT ENGINEER DATE 08/12/19  
 REGISTERED CIVIL ENGINEER  
 HEATHER GARDNER  
 No. 86989  
 Exp. 03/31/21  
 CIVIL  
 STATE OF CALIFORNIA

PLANS APPROVAL DATE  
 THE STATE OF CALIFORNIA OR ITS OFFICERS OR AGENTS SHALL NOT BE RESPONSIBLE FOR THE ACCURACY OR COMPLETENESS OF SCANNED COPIES OF THIS PLAN SHEET.

STANTEC CONSULTING  
 2646 SANTA MARIA WAY, SUITE 107  
 SANTA MARIA, CA 93455  
 COUNTY OF SANTA BARBARA  
 DEPARTMENT OF PUBLIC WORKS  
 123 EAST ANAPAMU STREET  
 SANTA BARBARA, CA 93101

CONTRACT No. 05-1F1004  
 PROJECT ID 0513000057

DATE PLOTTED: 08/12/19  
 TIME PLOTTED: 10:00 AM

THE CONTRACTOR SHALL POSSESS THE CLASS (OR CLASSES) OF LICENSE AS SPECIFIED IN THE "NOTICE TO BIDDERS."